
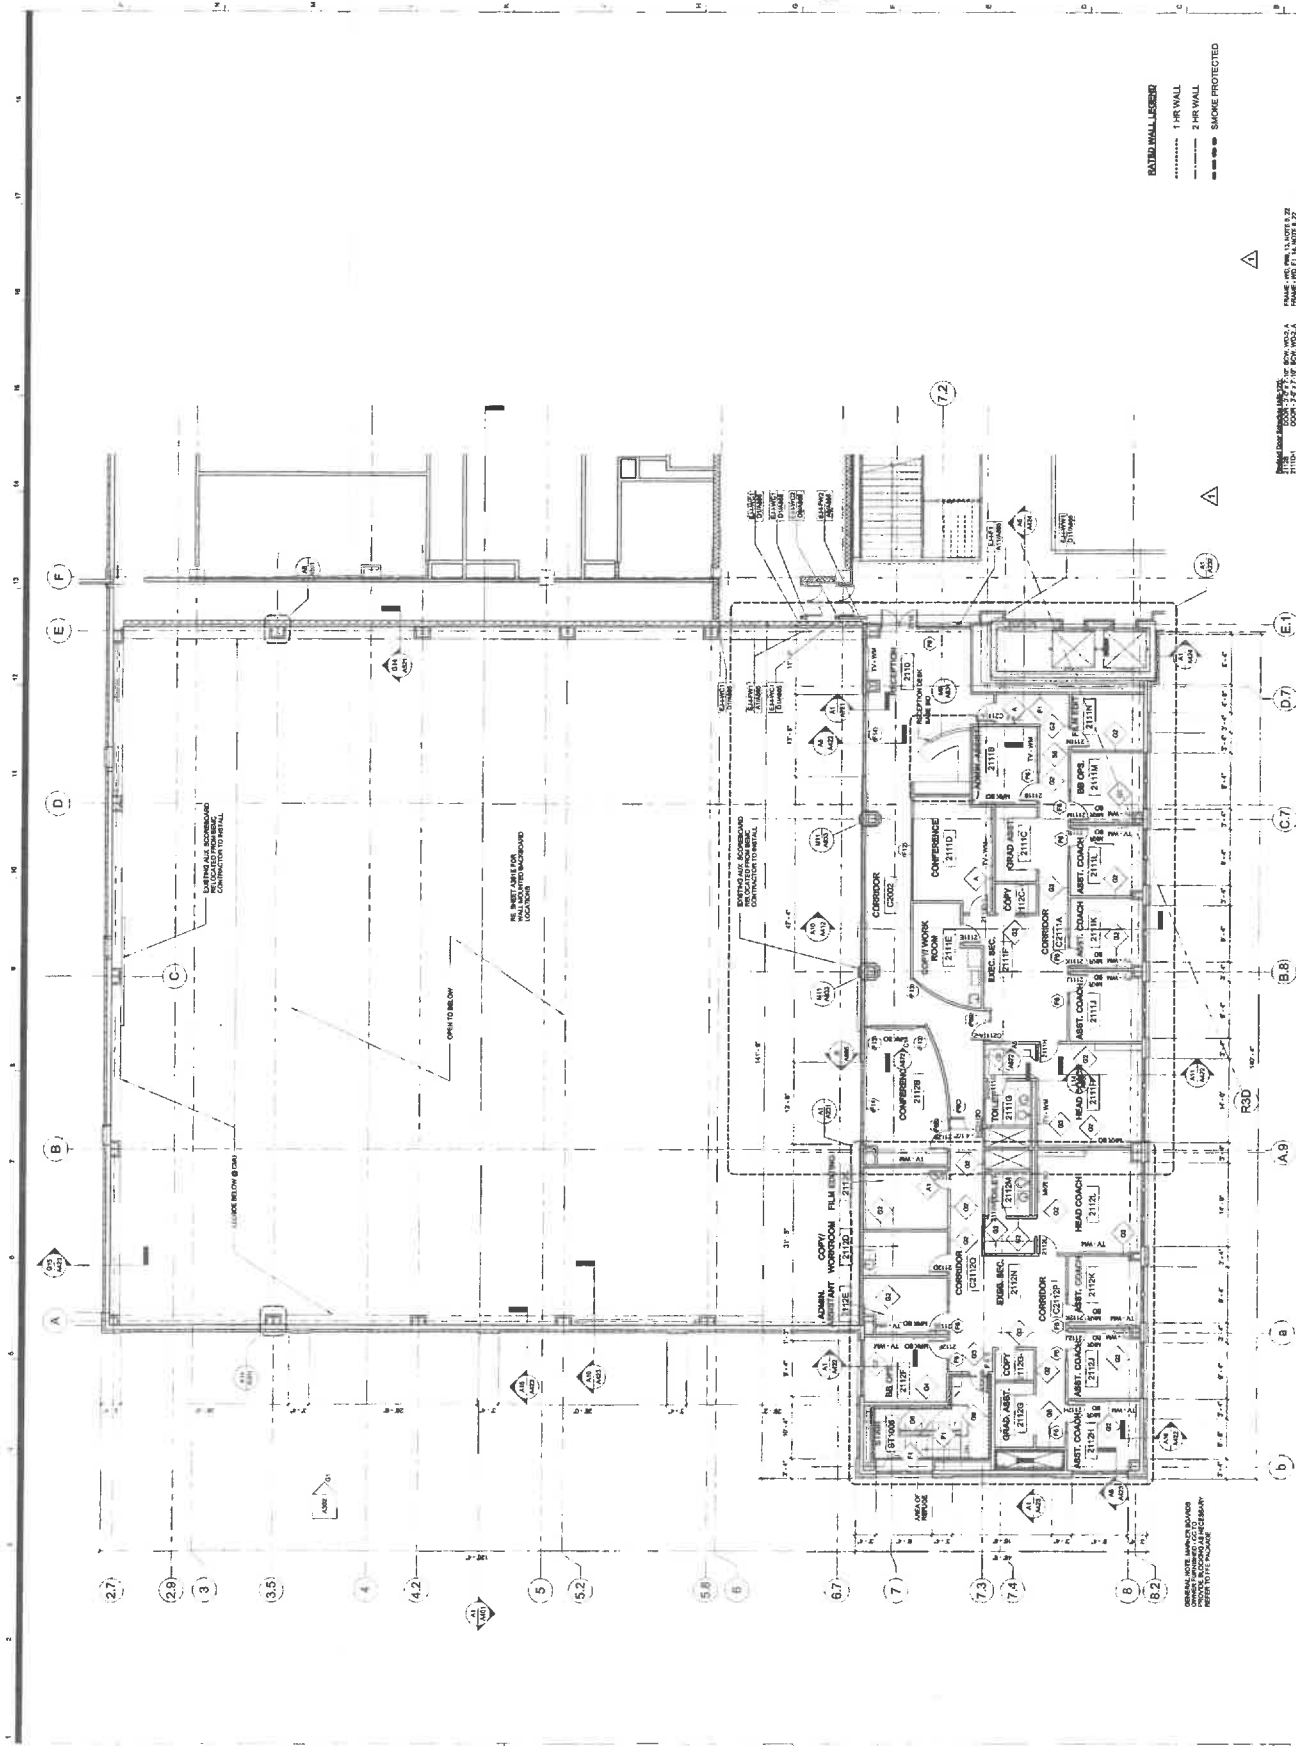



[illegible]

A1 Administration Level-Sector E

4504

4504

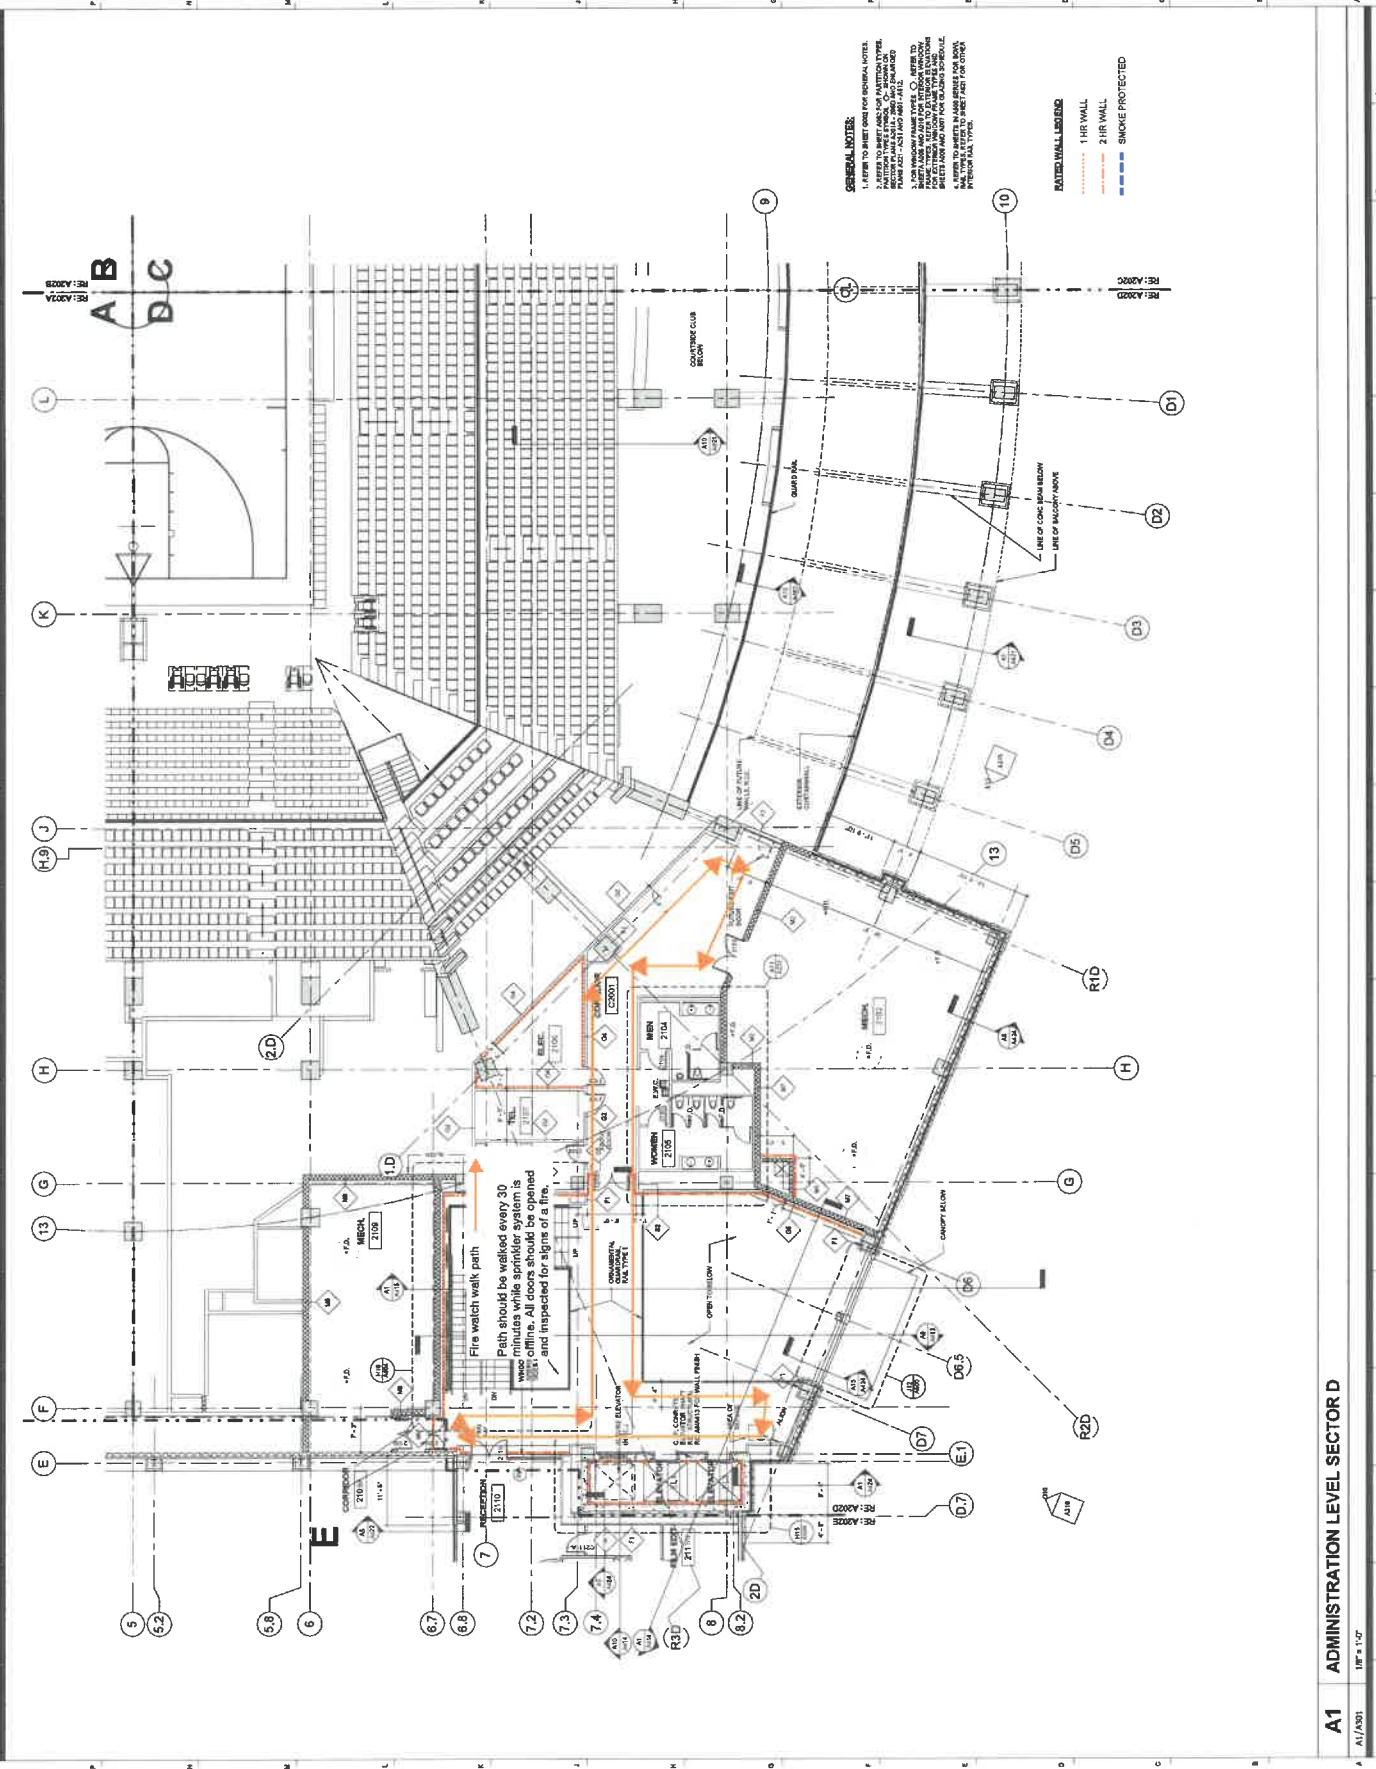

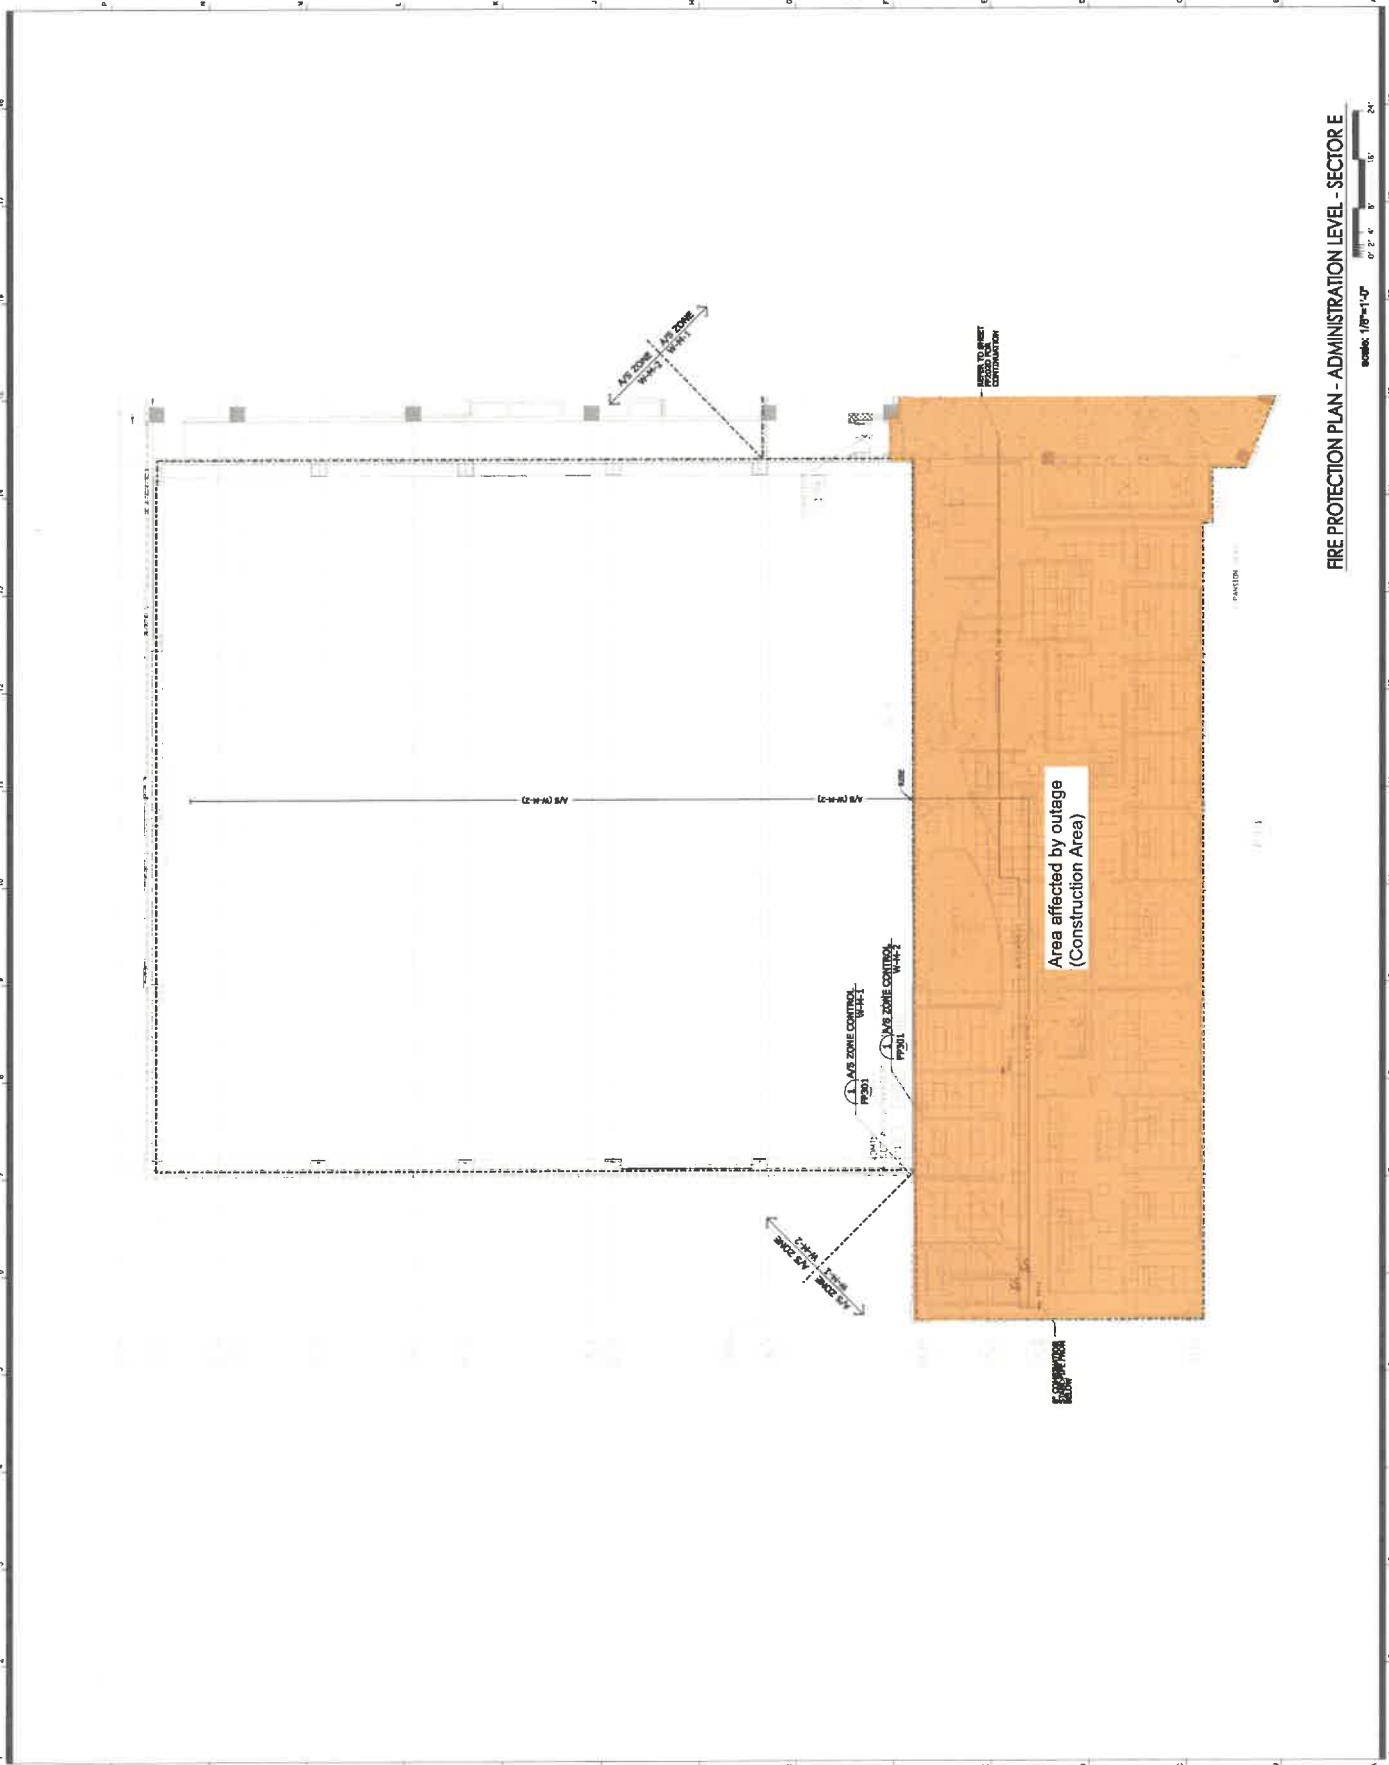

FIRE PROTECTION PLAN - ADMINISTRATION LEVEL - SECTOR E

Scale: 1/8"=1'-0"

0' 2' 4' 6' 8' 10' 12' 14' 16' 18' 20'

