



Chambers & Associates, L.L.C.


2000 PROGRESS DRIVE
SUITE 100
TAMPA, FL 33610
TEL: 813-252-0988
FAX: 813-252-0988



Project
RENOVATION OF
WILFRE ENGINEER
LABORATORY BLDG
APSCA 752-29

Sheet Title:

LARGE SCALE LOWER
LEVEL POWER PLAN
NORTHWEST

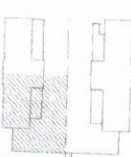

KEY PLAN

Issue Index Prior to Pull Review

Issue No.	Description	Date	By
1	Initial Design	10/1/00	RC
2	Revised Design	10/1/00	RC
3	Final Design	10/1/00	RC

Progress Print:
Revised for:
ES (Pull) Release:
By:
Date:

Revisions


Rev.	By	Date	Description
1	RC	10/1/00	Initial Design
2	RC	10/1/00	Revised Design
3	RC	10/1/00	Final Design

Drawn By: RC
Checked By: RC
Owner Number: 10-25
CA Number: 752-29
Sheet Number


E3.1

Sequence Number: 10 of 11

LARGE SCALE LOWER LEVEL POWER PLAN - NORTHWEST
10/1/00

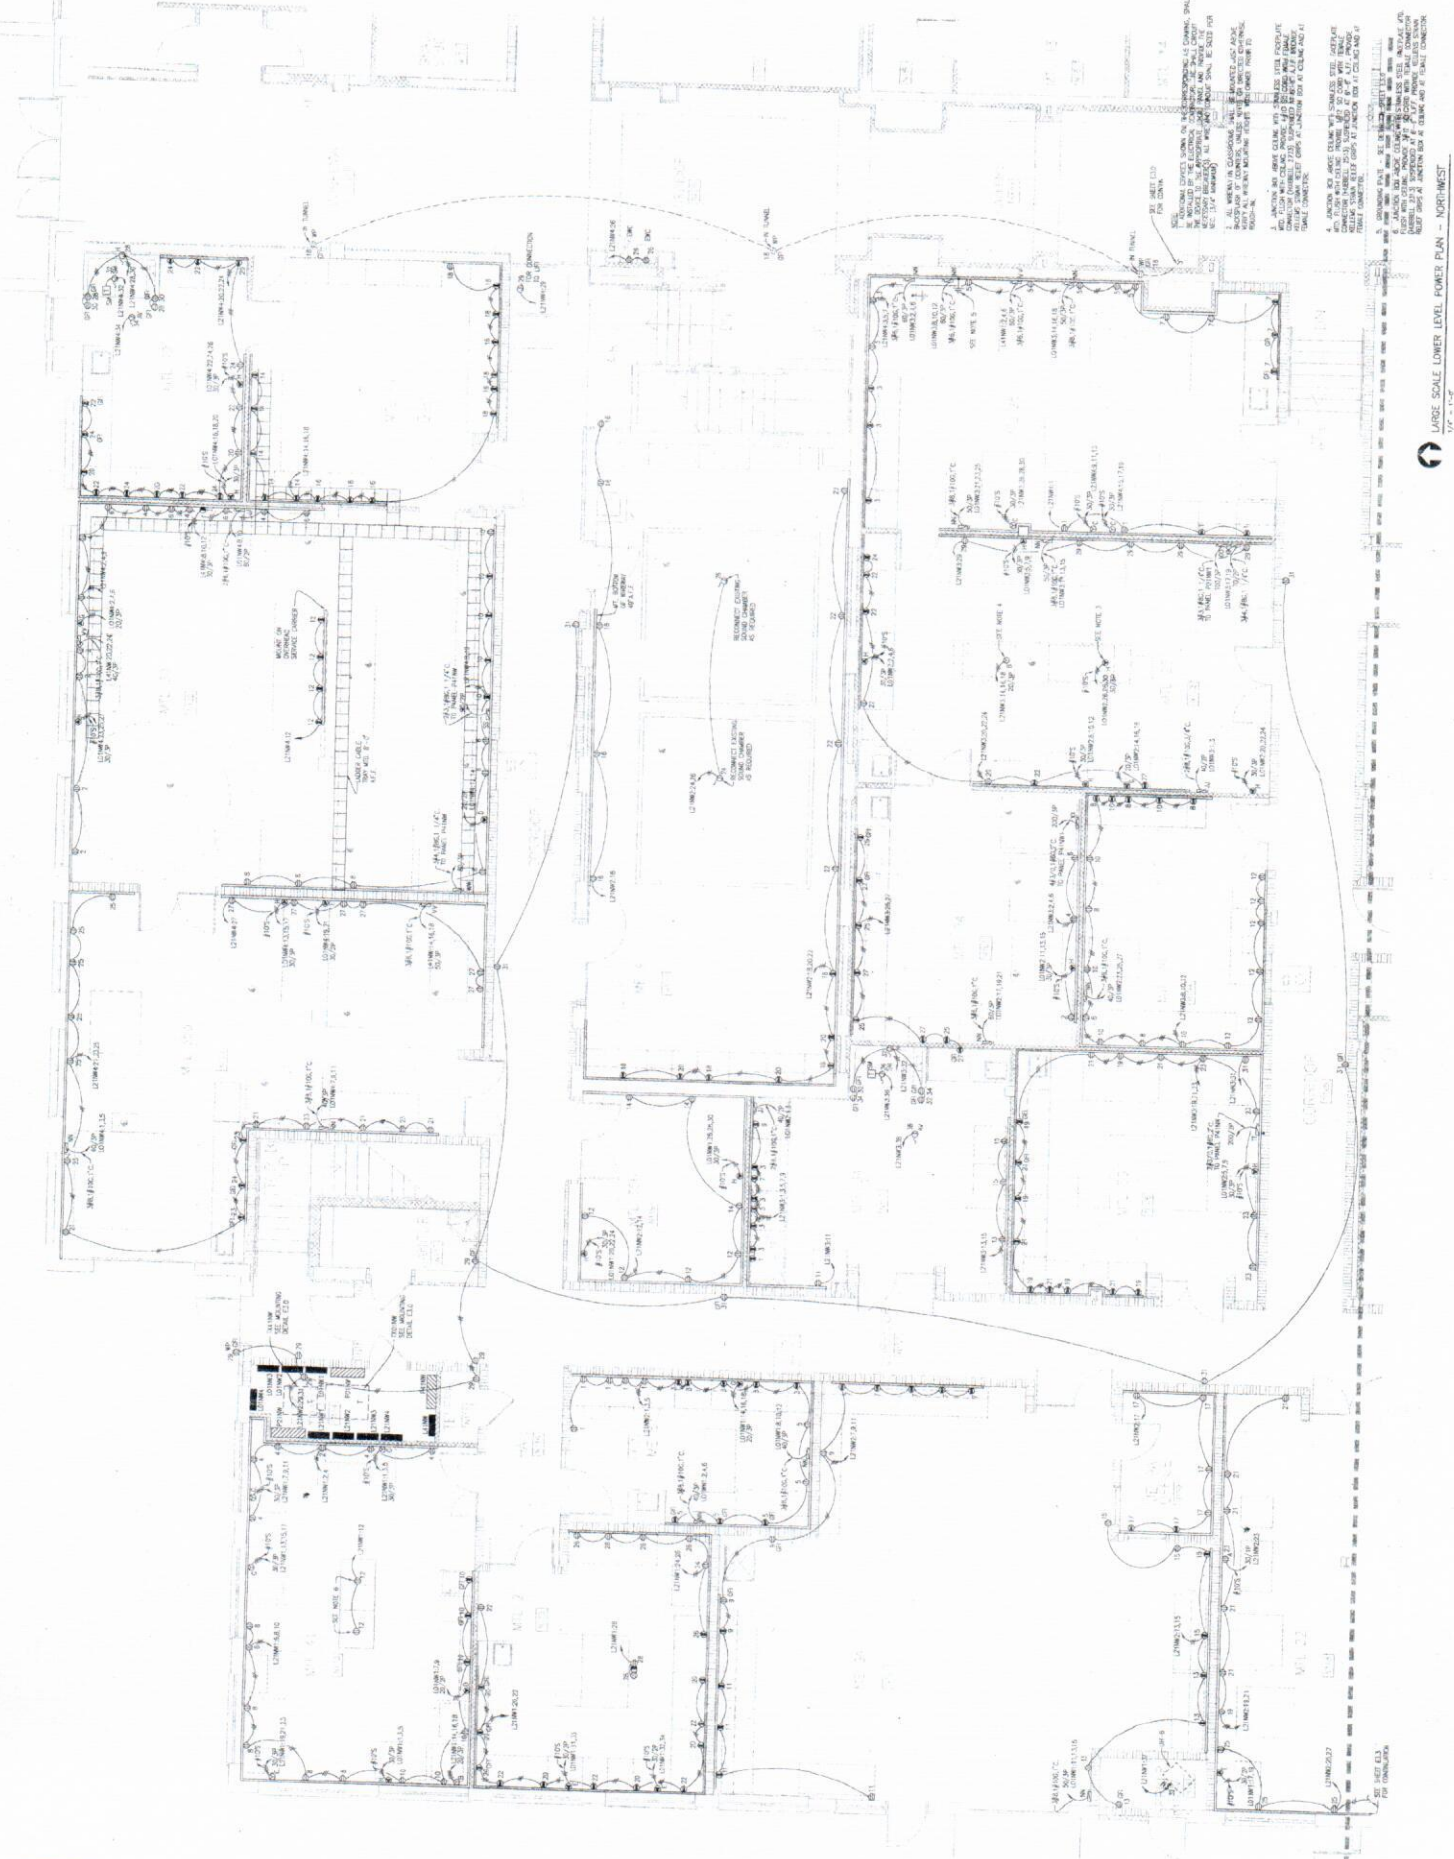

DEPARTMENT		AREA
Chemical Engineering		12,489
Civil Engineering		970
Engineering Admin		276
Mechanical Engineering		17,676
Nonassessable Area		12,537
TOTAL		46,948
Floor Gross		51,532

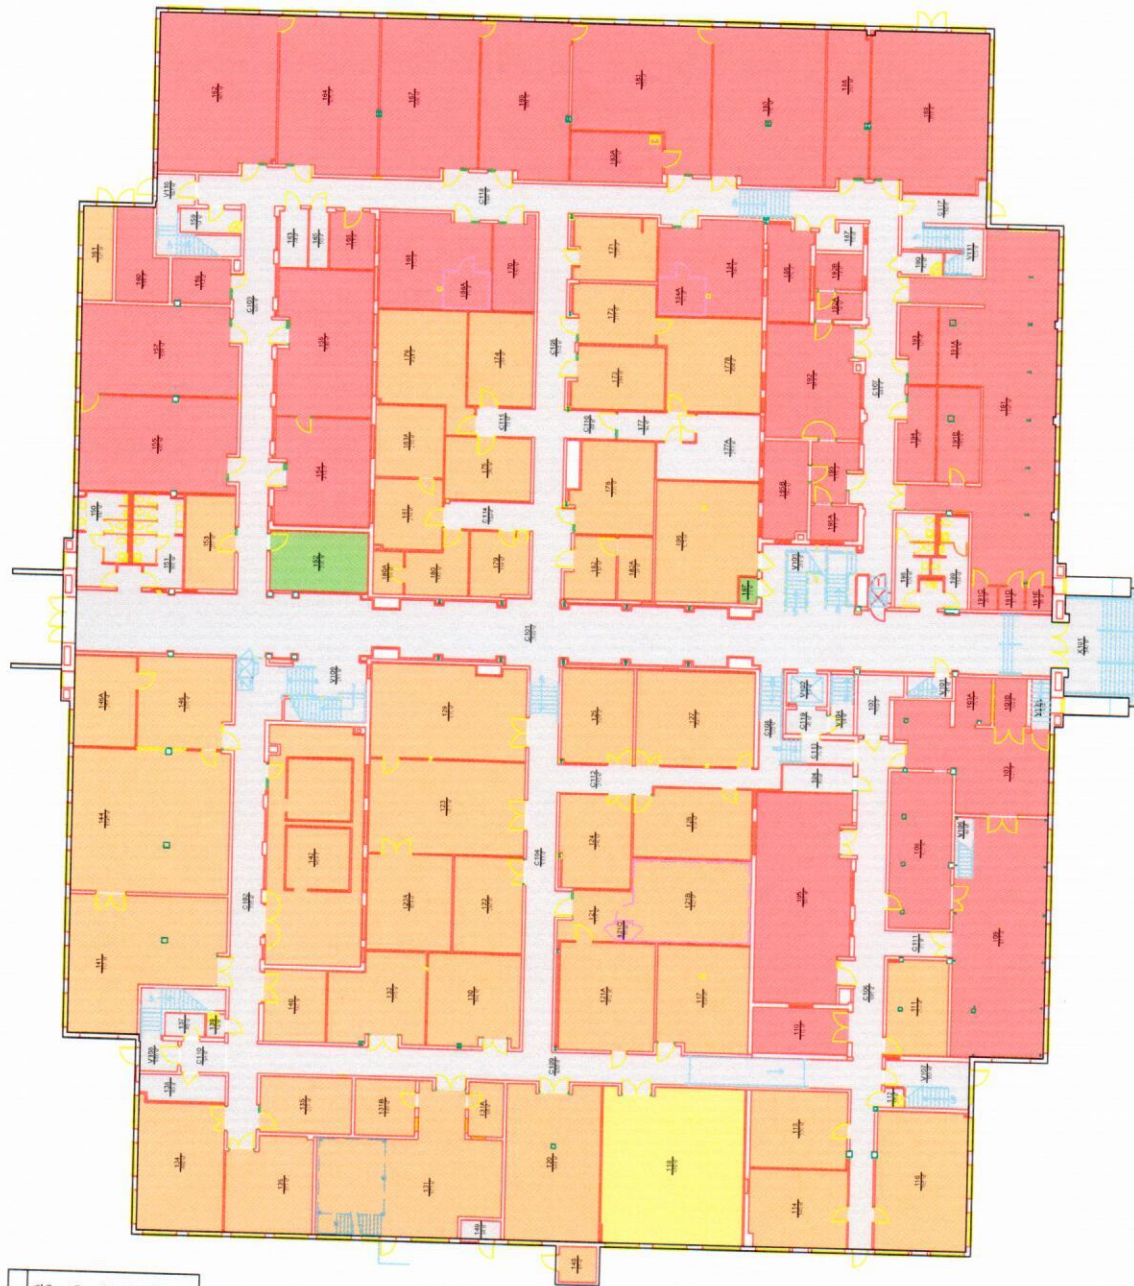

Office of the
University Architect
Facilities Management
1161 West Sanford Ave., Building 1
Auburn, AL 36849



DEPARTMENT Wilmore Laboratories First Floor

Building No.: AA_W0205
File Name: AA_W0205_01
Last Export: 06/23/2015
Report Created By: Ellen Doyle
Report Date: 04/11/2017