



COLLEGE OF HUMAN SCIENCES: CHEER AND MARRIAGE AND
FAMILY THERAPY AT ARTS BUILDING 1 (SECOND FLOOR)

270 DRAIN DR
AUBURN, AL 36849

DOI: 10.1002/anie.202112919


[illegible]

KEY PLAN

DRAWING NAME:
SECOND FLOOR DEMOLITION PLAN -
DOMESTIC WATER

P1.0

PD / SD / DD / CD

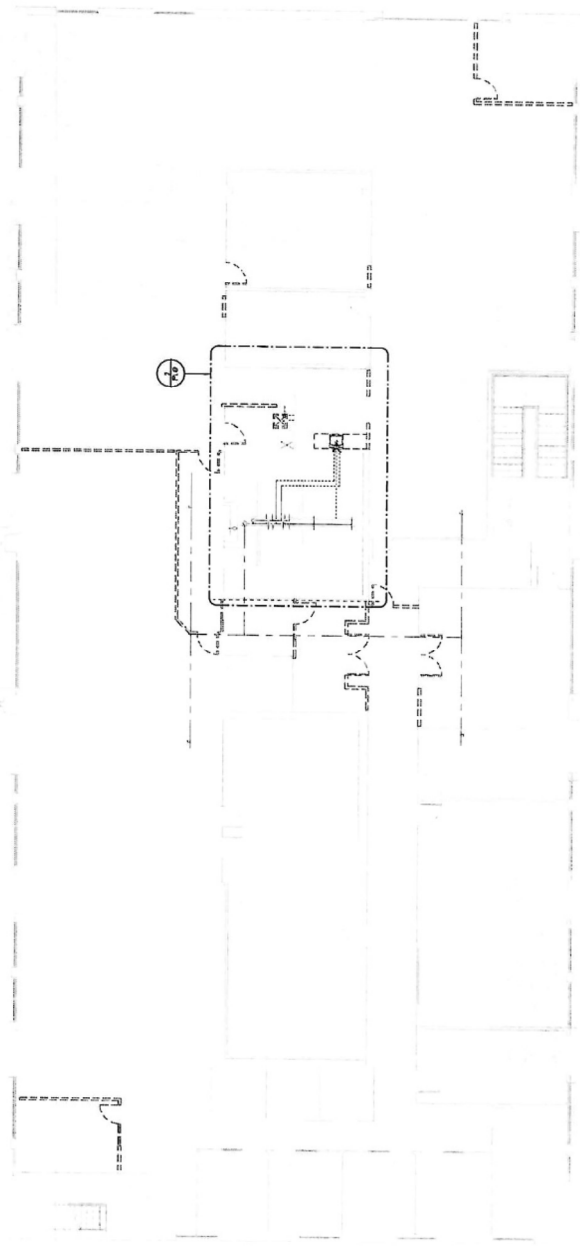

1 SECOND FLOOR DEMOLITION PLAN - DOMESTIC WATER
1/8" = 1'-0"


GENERAL NOTES:

- SEE P-91 FOR PUMPING LEGEND, SYMBOLS & ABBREVIATIONS.
- DETAILS ARE APPLICABLE EVEN IF THEY ARE NOT DIRECTLY REFERENCED.
- PIPING AT LINES OF CONSTRUCTION SHALL BE CAPTIED, REALLED AND INSULATED WITH MATERIALS OF LIKE KIND AND THICKNESS.

☒ ITEMS UNDERNEATH MATCHING TO BE DELETED.

KEY NOTES:

1 REMOVE FOAMING AND ALL ASSOCIATED PIPING AND ACCESSORIES. CAP AND SEAL ANY PIPING WITHIN WALL OR ABOVE CEILING.

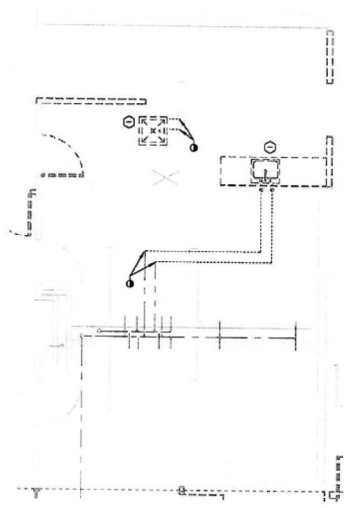

2 ENLARGED DEMOLITION PLAN - DOMESTIC WATER



AUBURN UNIVERSITY
FACILITIES MANAGEMENT
1000 UNIVERSITY BLVD
AUBURN, AL 36849
256.844.4444



STACY NORMAN
ARCHITECTS LLC
AUBURN, AL

COLLEGE OF HUMAN SCIENCES: CHEER AND MARRIAGE AND
FAMILY THERAPY AT ARTF BUILDING 1 (SECOND FLOOR)

575 Oliver Drive
Auburn, AL 36849
Project # 21-155
Date: 12/15/2021


REV	DATE	DESCRIPTION
1	12/15/2021	CONSTRUCTION SET



SEAL & SIGNATURE
KEY PLAN


DRAWING NAME:
SECOND FLOOR PLAN - DOMESTIC WATER

P2.0
PD / SD / DD / CD

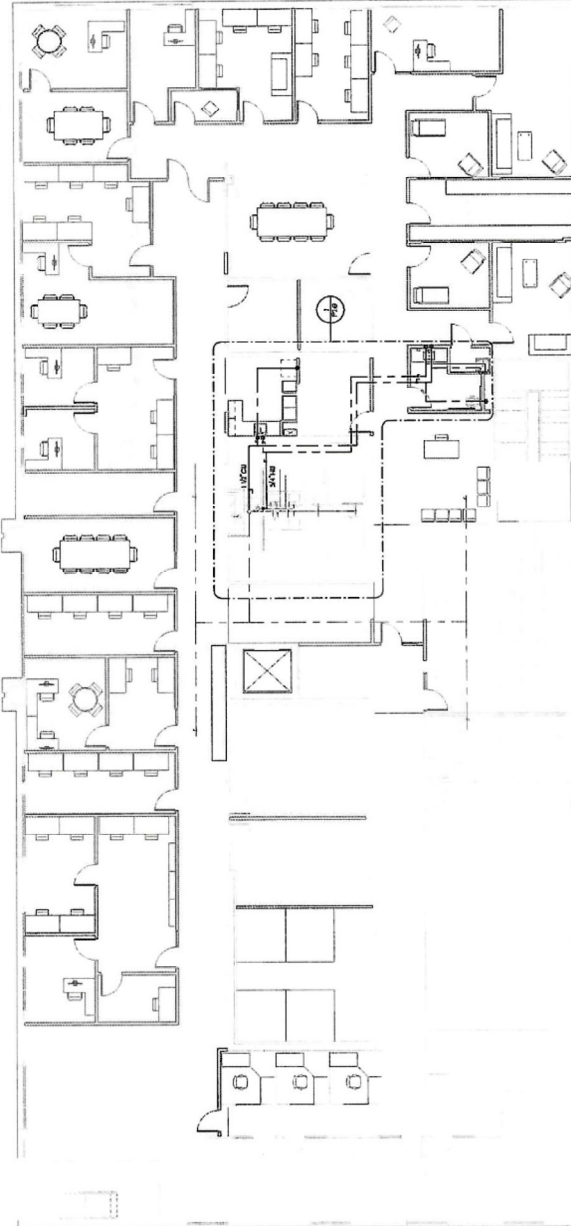

1 SECOND FLOOR NEW - DOMESTIC WATER
1/8" = 1'-0"

GENERAL NOTES:
- SEE ALL FLOOR PLANS FOR ROOMS, SYSTEMS, & DIMENSIONS.
- ALL WORK SHALL BE IN ACCORDANCE WITH THE LATEST EDITIONS OF THE INTERNATIONAL MECHANICAL, ELECTRICAL, & PLUMBING (IMEP) CODE.
- ALL WORK SHALL BE IN ACCORDANCE WITH THE LATEST EDITIONS OF THE AIAA CODE AND TYPICALS.

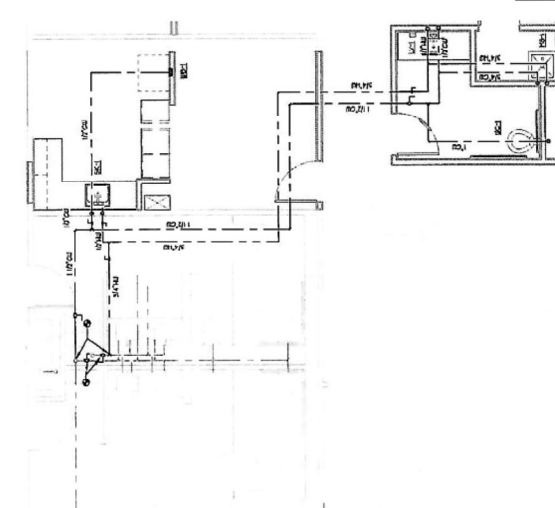

CONWAY & OWEN
2015 South Main Street, Suite 300
Auburn, AL 36849
Phone: 256.844.4444
Fax: 256.844.4445
www.conwayandowen.com

2 ENLARGED NEW FLOOR PLAN - DOMESTIC WATER
1/8" = 1'-0"



AUBURN UNIVERSITY
UNIVERSITY MICROFILMS
SERIALS ACQUISITION
300 N. ZEEB RD.
ANN ARBOR, MI 48106-1500
616.763.4000



COLLEGE OF HUMAN SCIENCES: CHEER AND MARRIAGE AND
FAMILY THERAPY AT ARTF BUILDING 1 (SECOND FLOOR)


570 David Drive
Auburn, AL 36849
205.844.2021

DATE	12/10/2021
BY	
CHK	
APP	
CONFIRMANCE	HC




REVISION

DRAWING NAME:
RISER - PLUMBING
P3.0
PD / SD / DD / CD

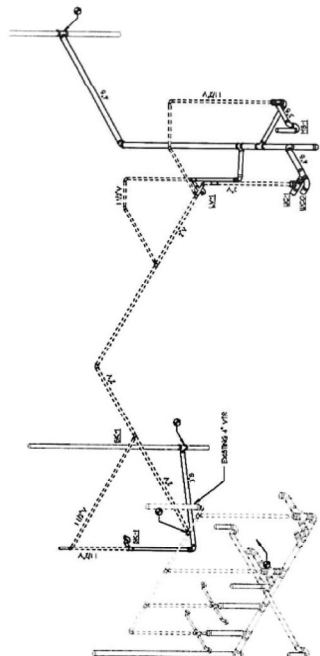

1 SECOND FLOOR PLAN NEW - SANTARY AND VENT - RISER DIAGRAM

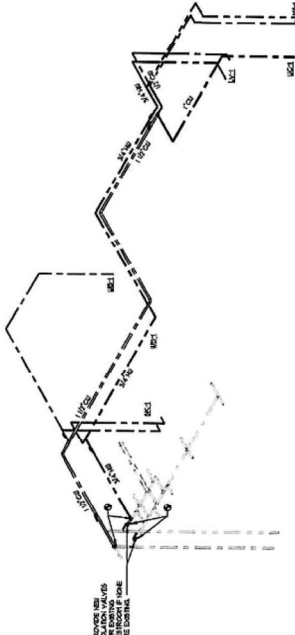

2 SECOND FLOOR PLAN NEW - DOMESTIC WATER - RISER DIAGRAM

